



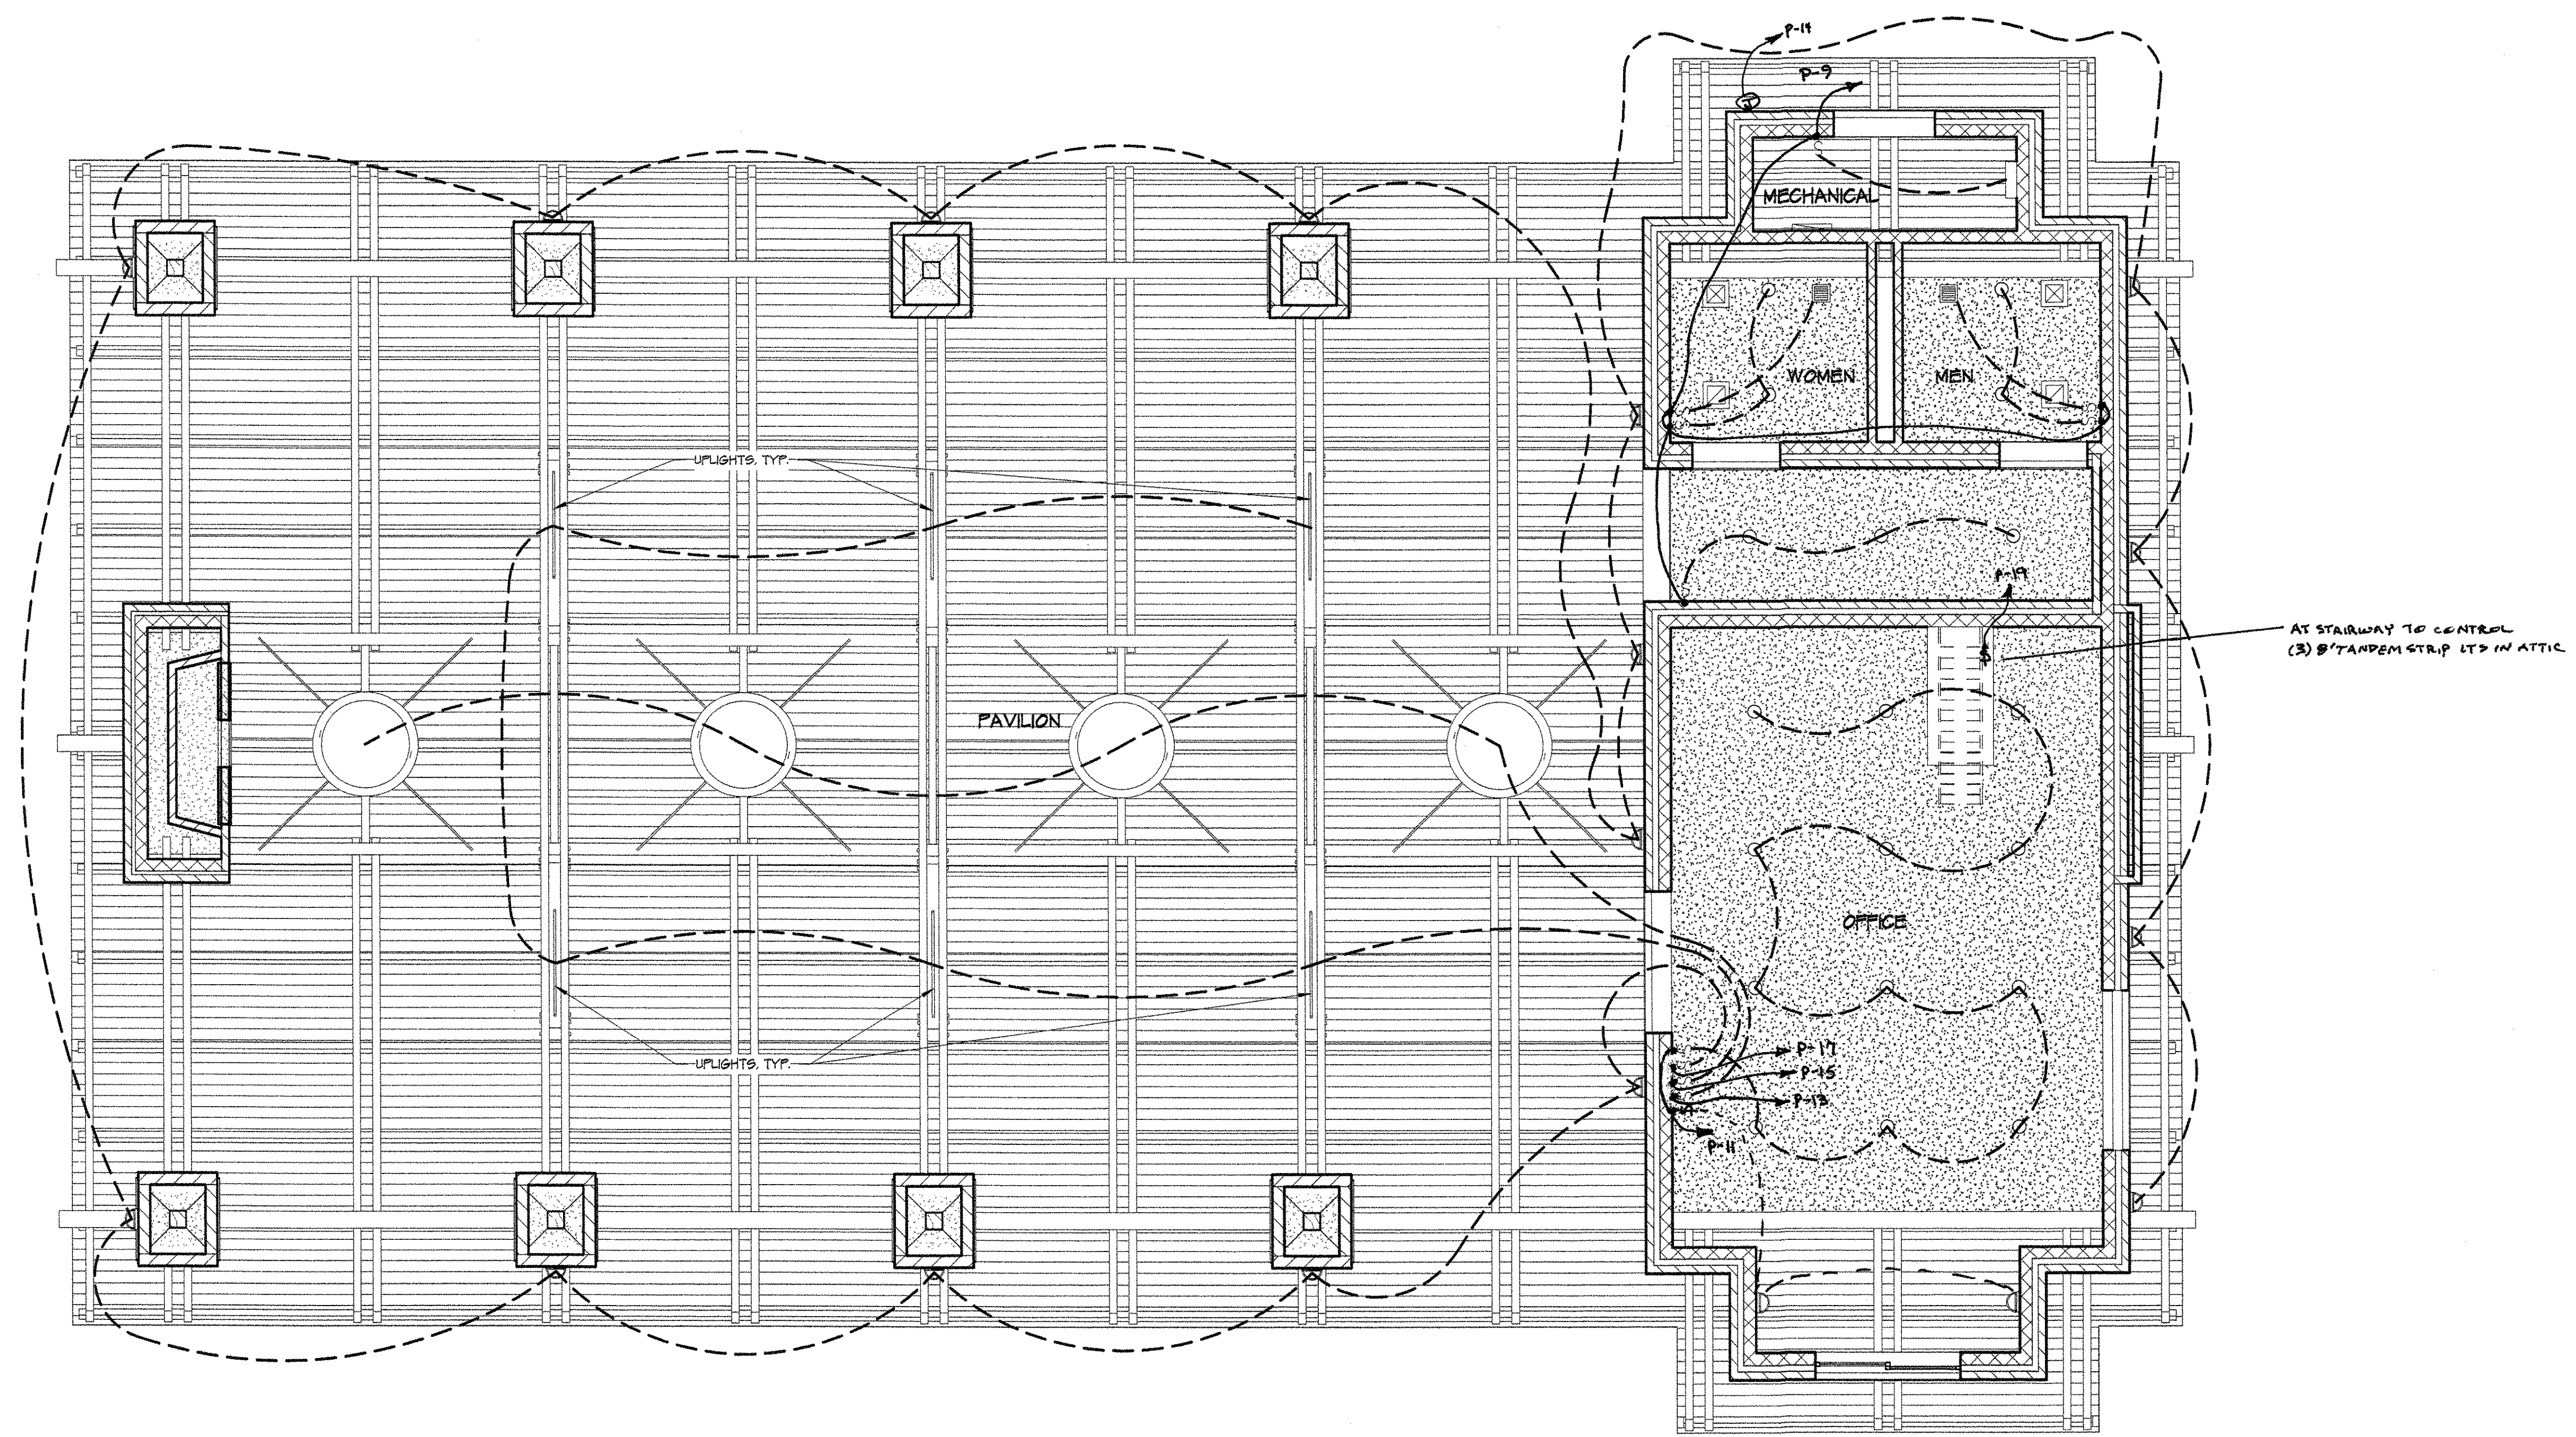

1 REFLECTED CEILING PLAN
 SCALE: 1/4" = 1'-0"

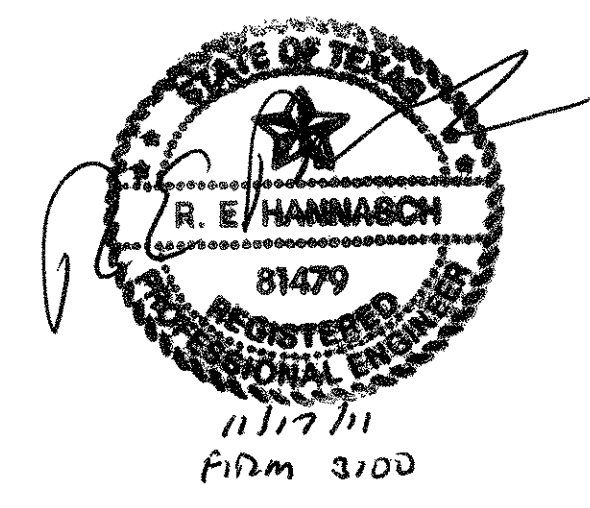

TOWER ELECTRIC

946 AT&T CENTER PARKWAY
 SAN ANTONIO, TX 78219
 PHONE: 210-590-7333 • FAX: 210-590-3244

STEVEN'S RANCH
 RECREATION CENTER