




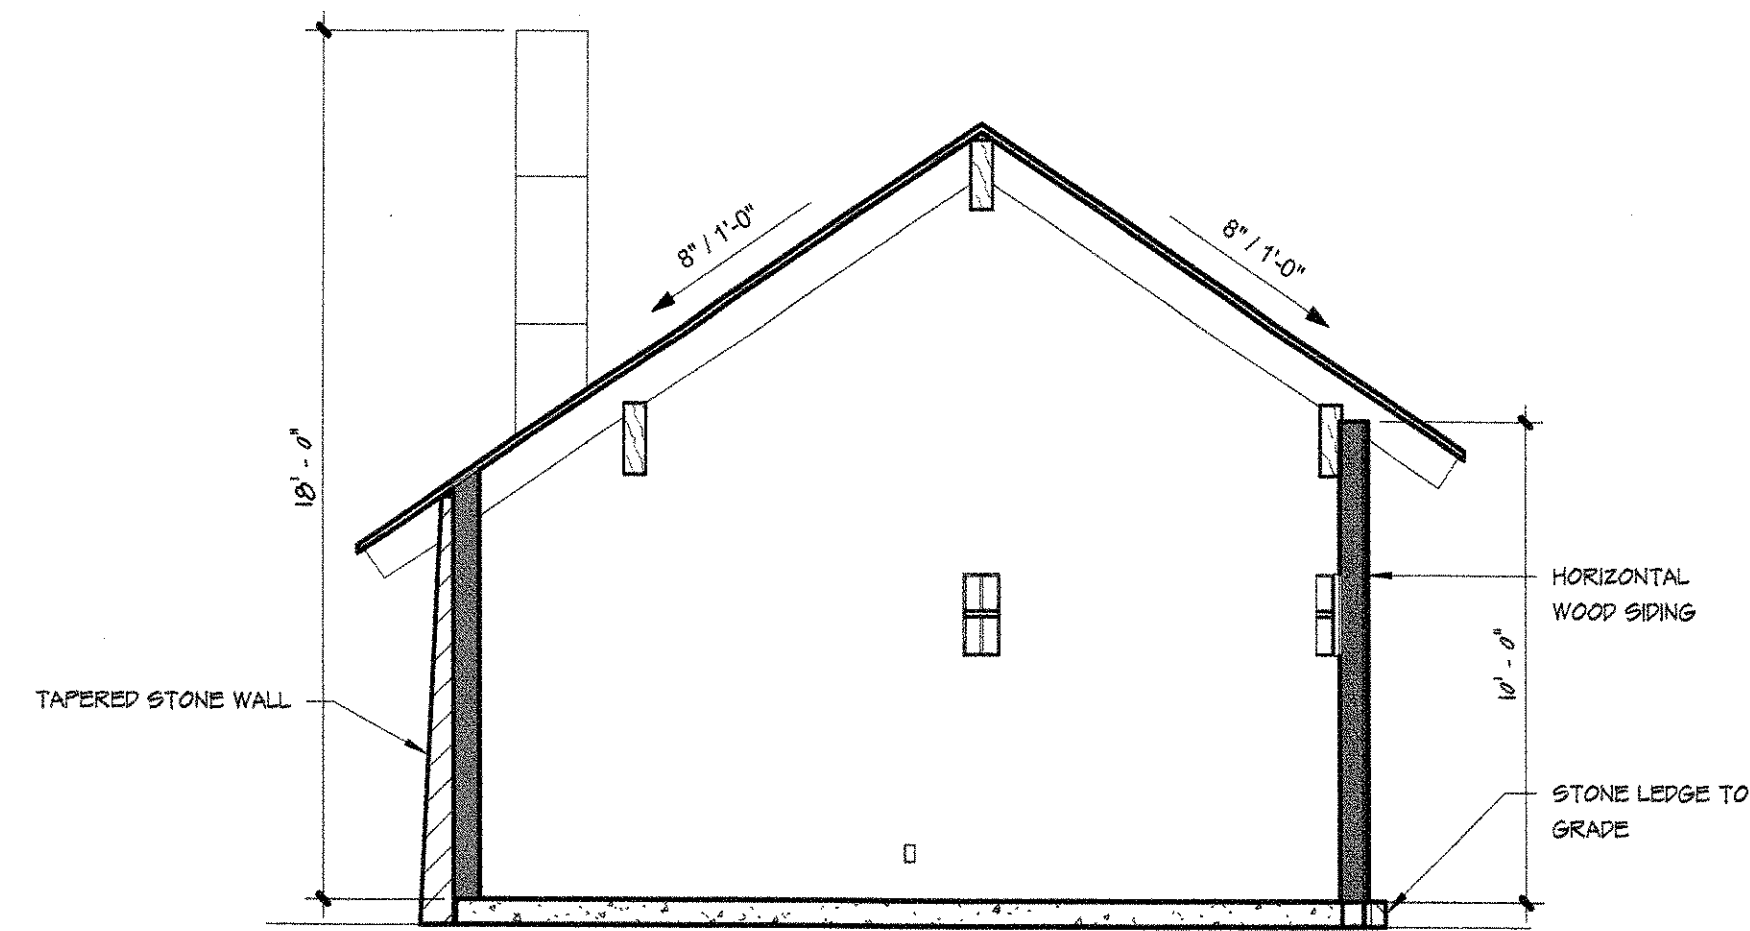


7 BUILDING SECTION
SCALE: 1/4" = 1'-0"

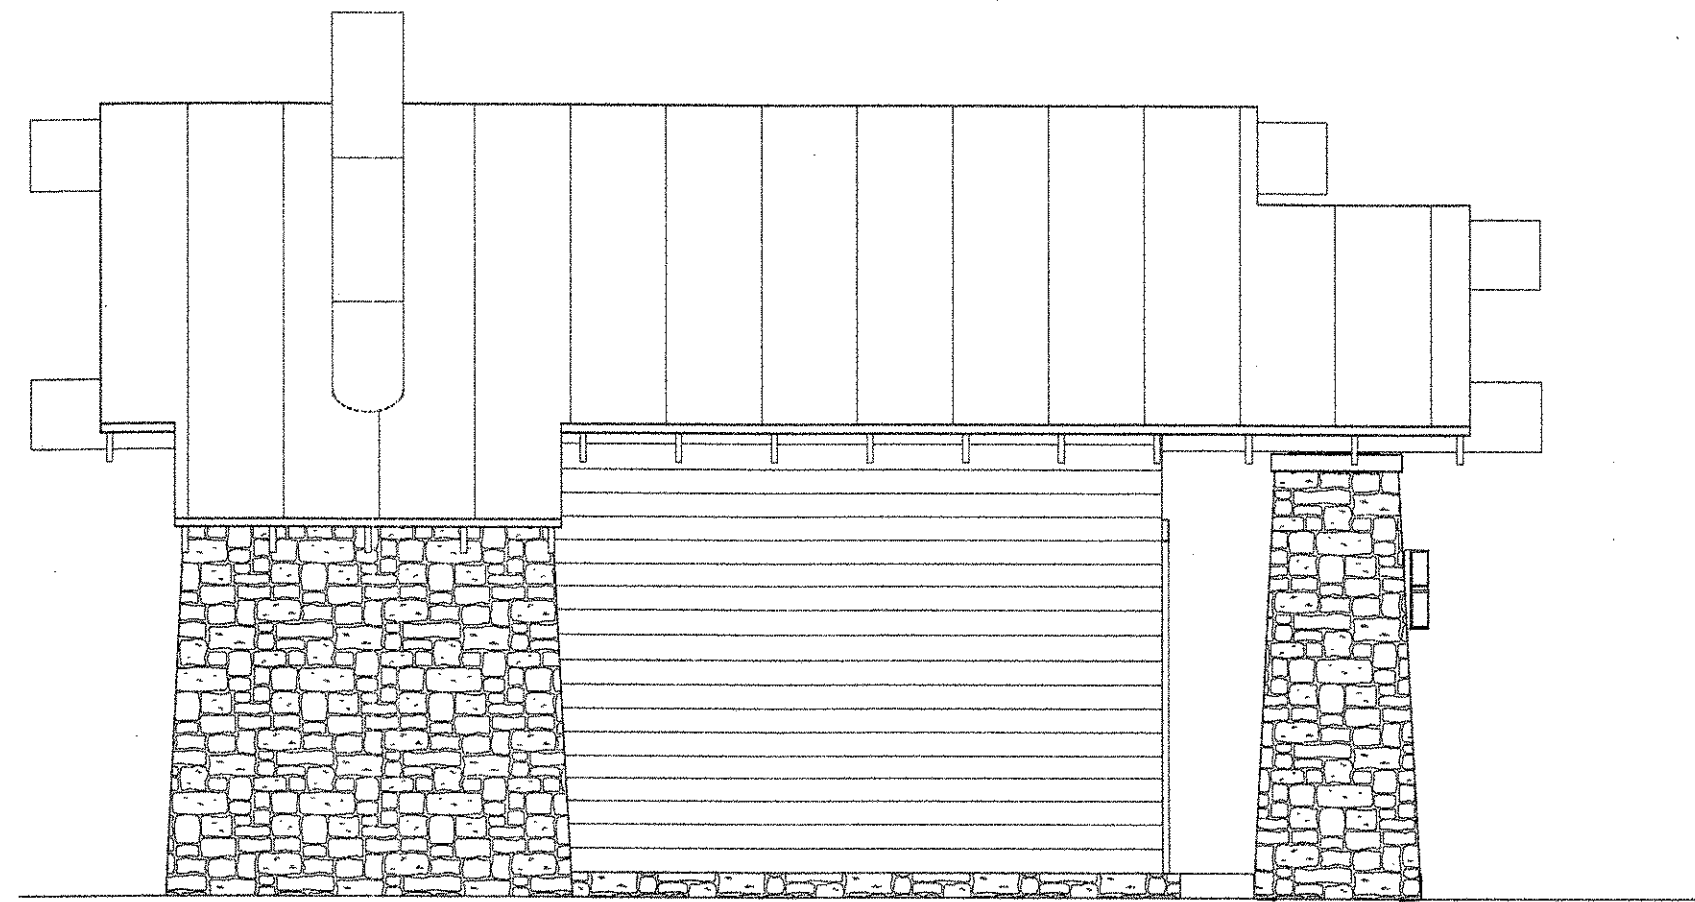


4 SOUTH ELEVATION - POOL HOUSE
SCALE: 1/4" = 1'-0"

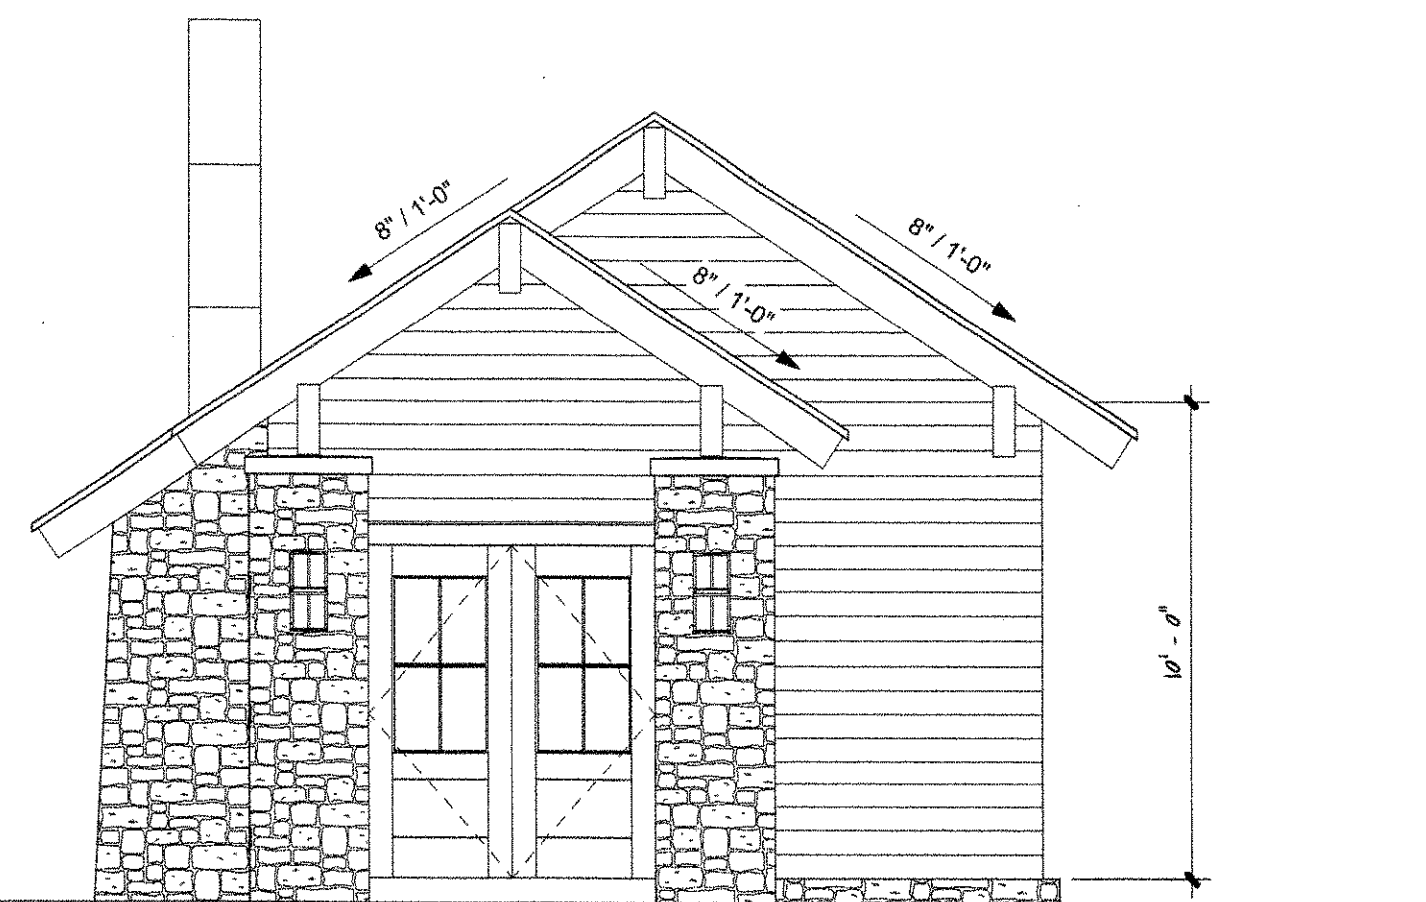


5 EAST ELEVATION - POOL HOUSE
SCALE: 1/4" = 1'-0"

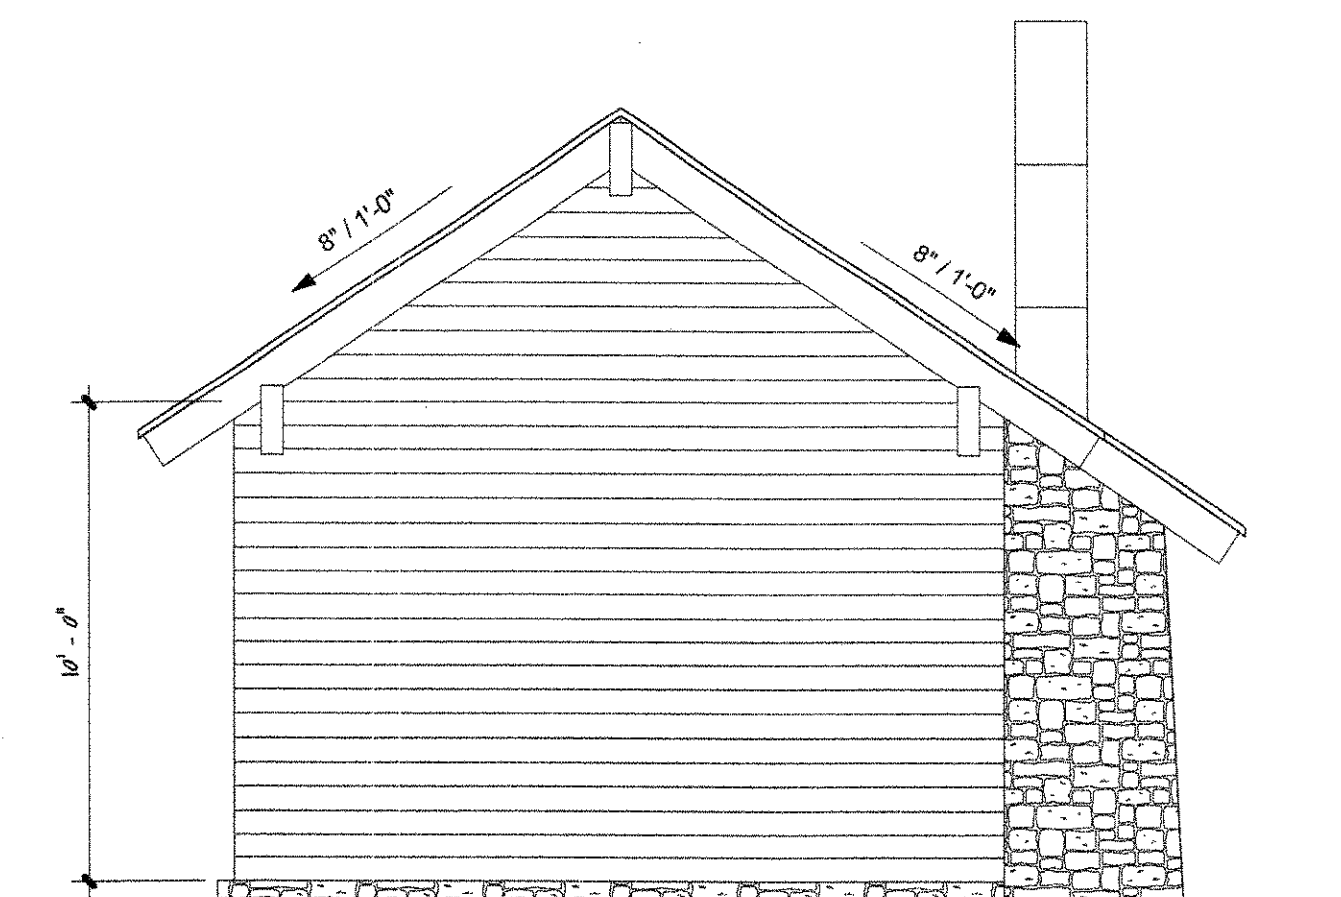


3 WEST ELEVATION - POOL HOUSE
SCALE: 1/4" = 1'-0"

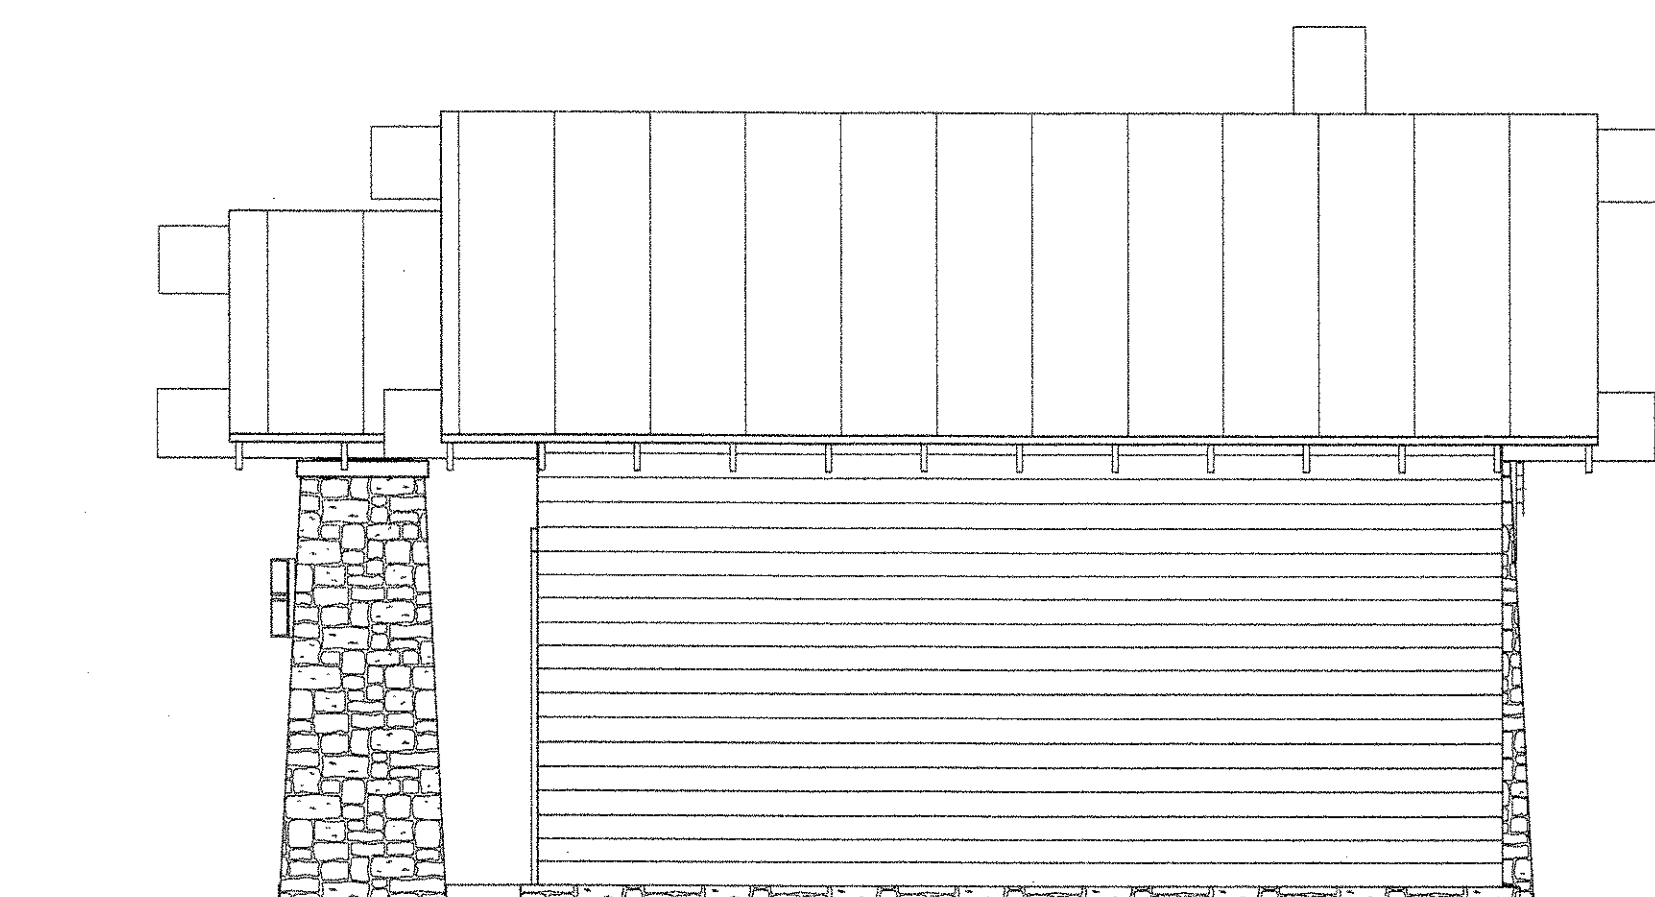


2 NORTH ELEVATION - POOL HOUSE
SCALE: 1/4" = 1'-0"

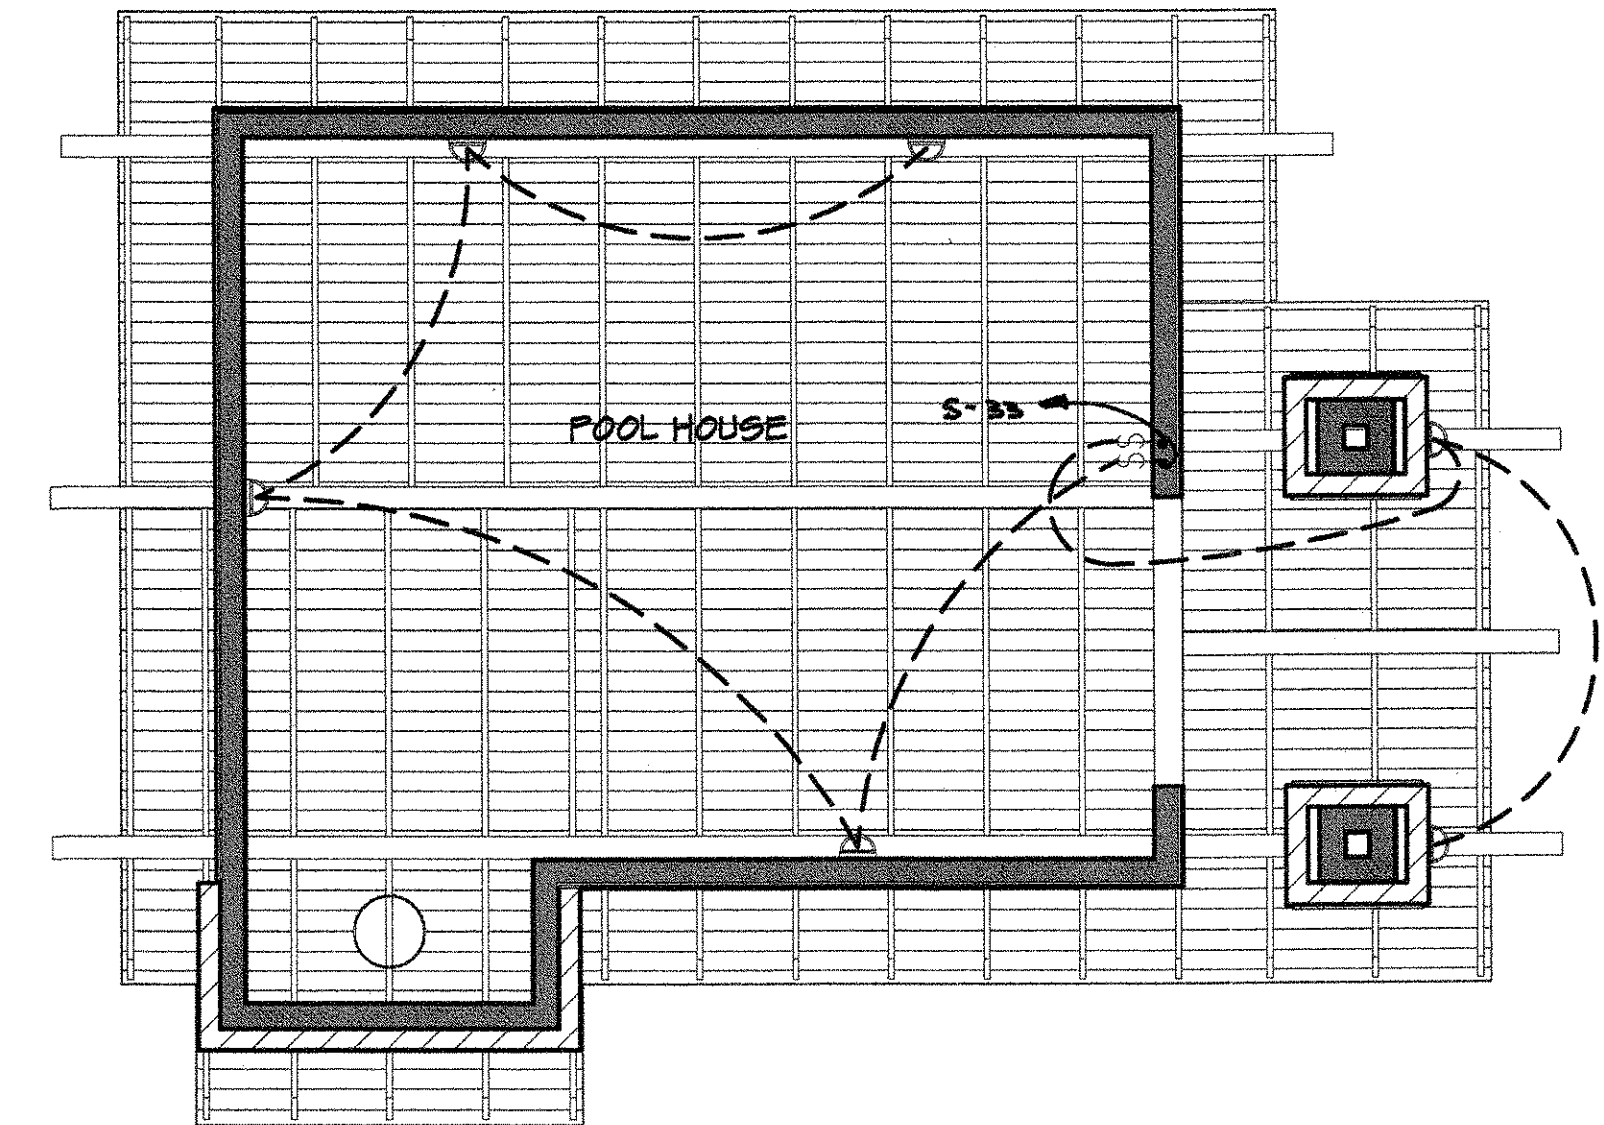

6 REFLECTED CEILING PLAN
SCALE: 1/4" = 1'-0"

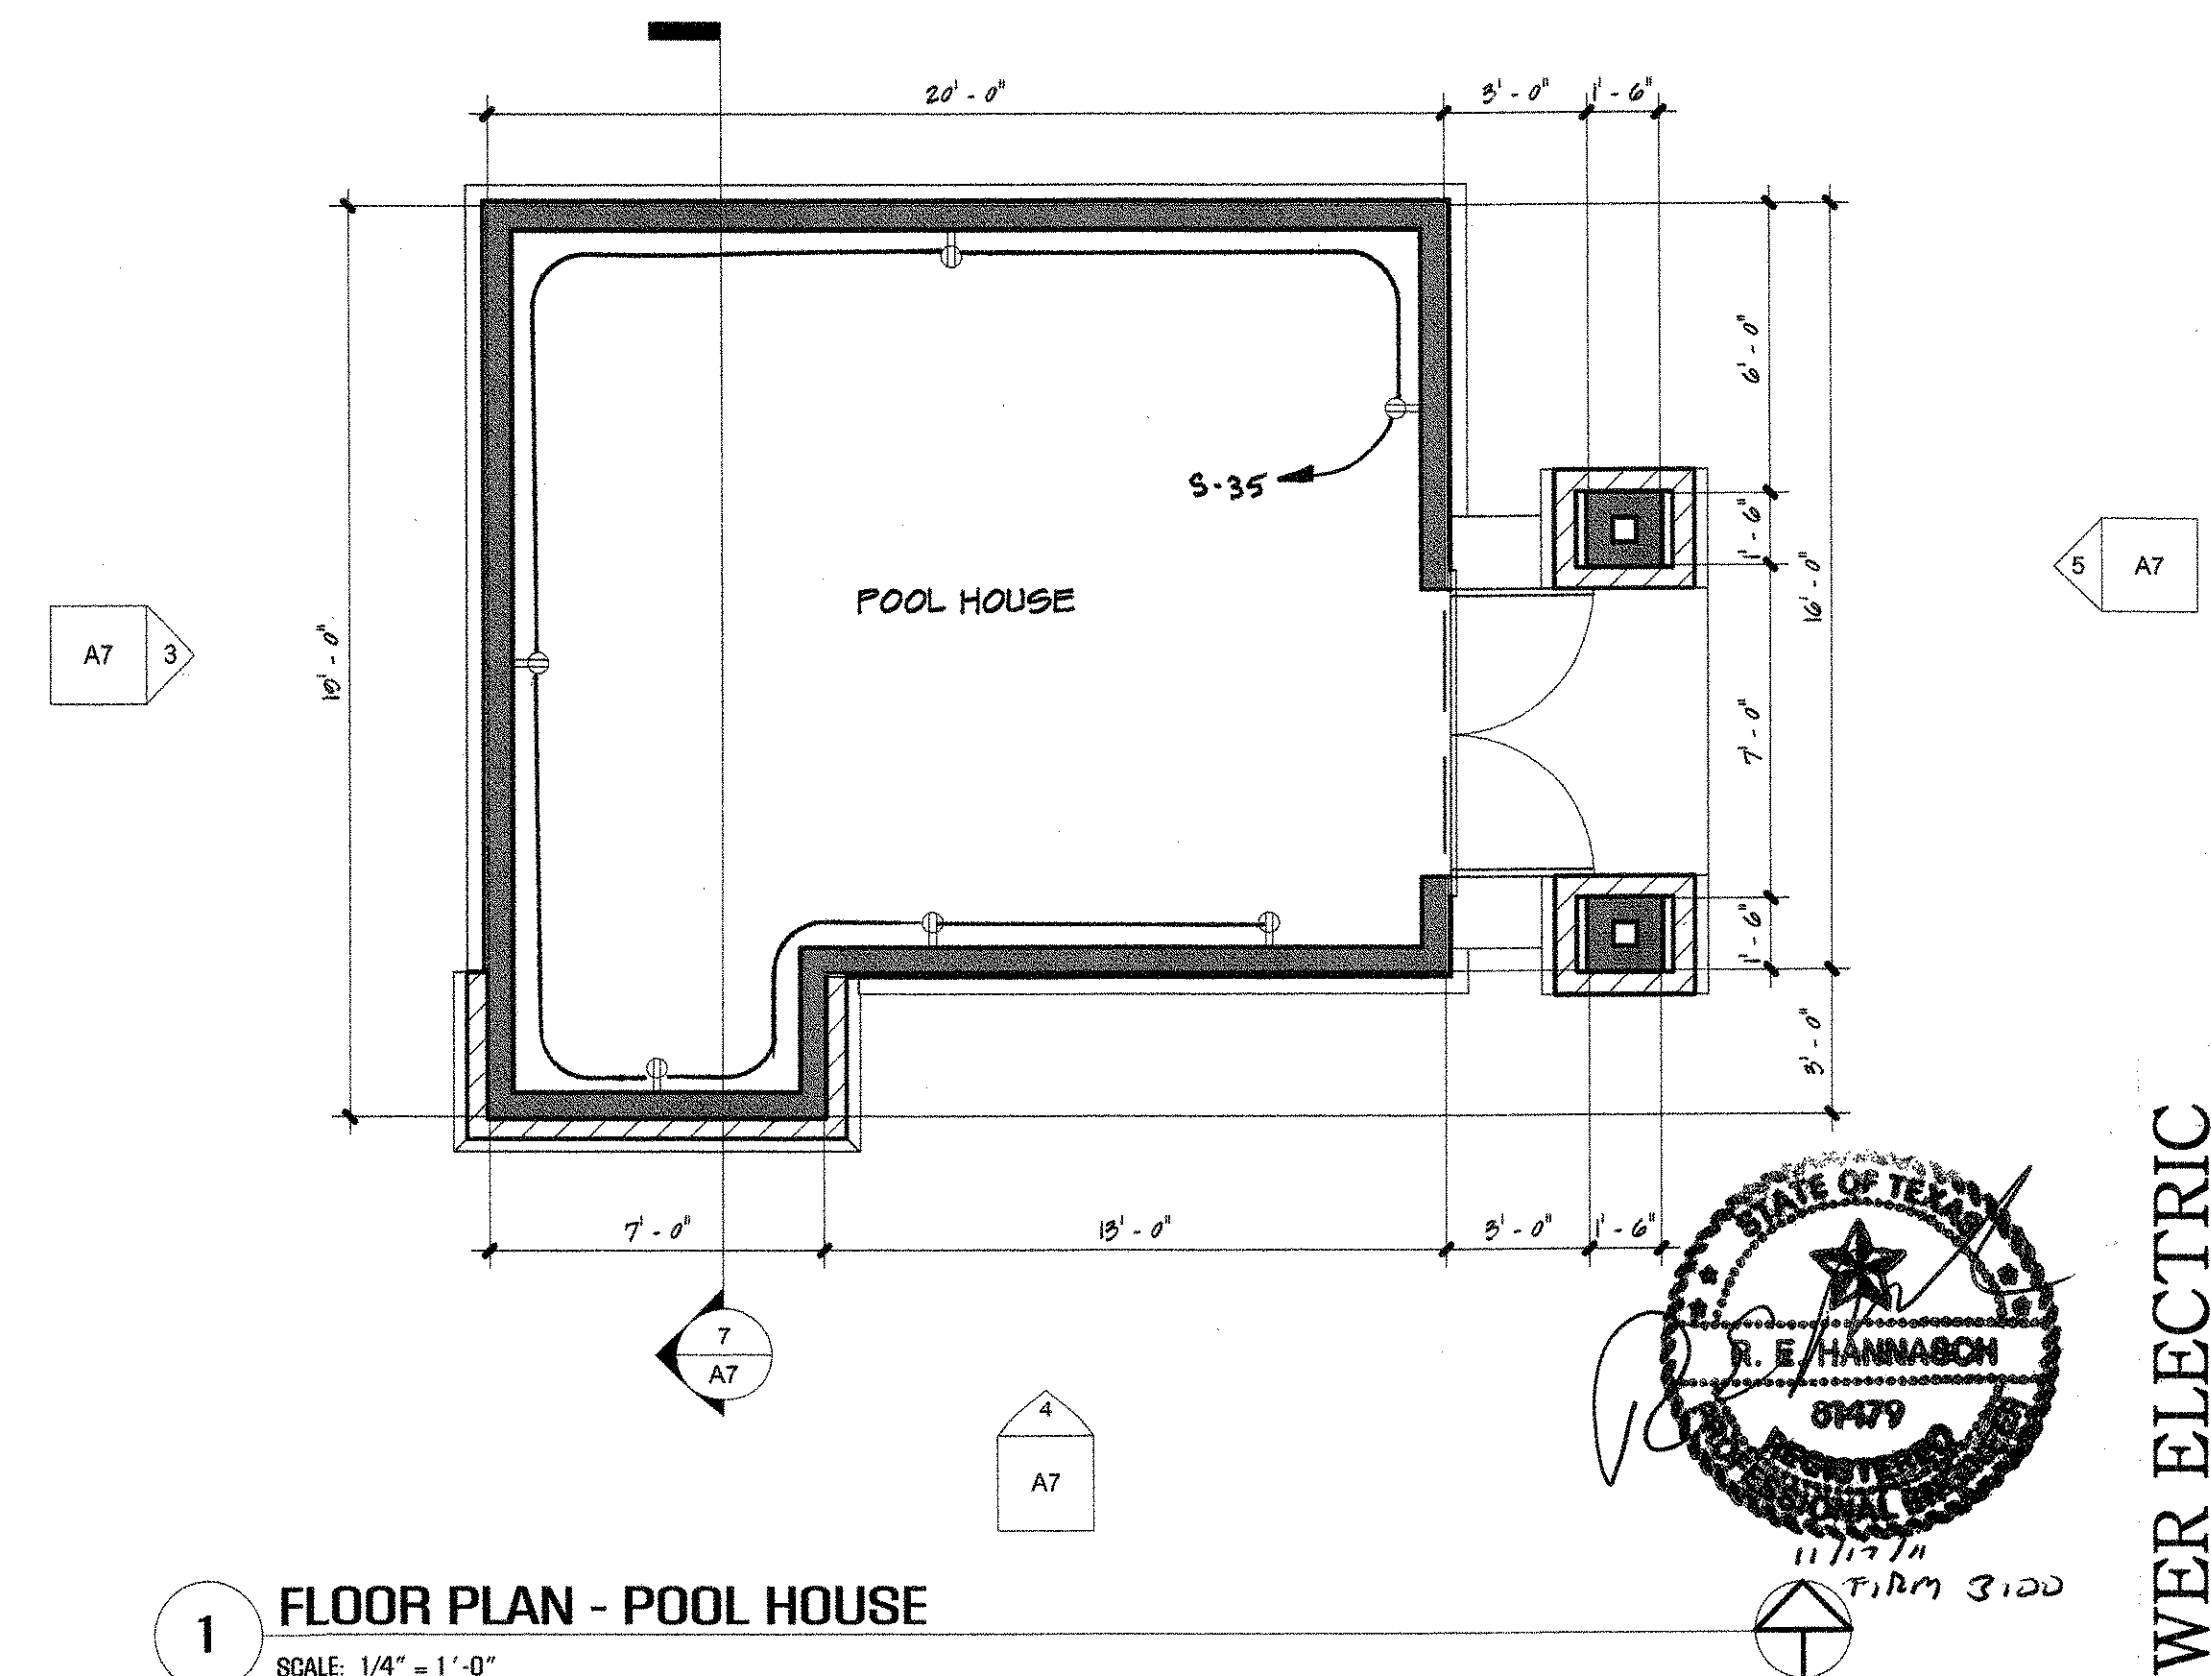

1 FLOOR PLAN - POOL HOUSE
SCALE: 1/4" = 1'-0"

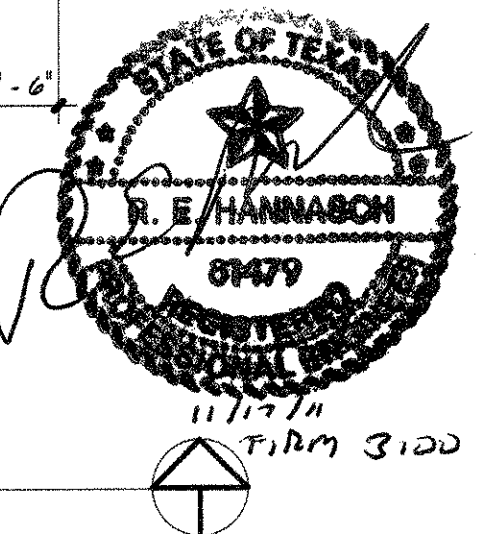

TOWER ELECTRIC
946 AT&T CENTER PARKWAY
SAN ANTONIO, TX 78219
PHONE: 210-590-7333 * FAX: 210-590-3244

**STEVENS RANCH
RECREATION CENTER**

A NEW PAVILION FOR
STEVENS RANCH

SHEET CONTENTS: POOL HOUSE

NOVEMBER 04, 2011

E-4